



SECTION A-A DETAIL

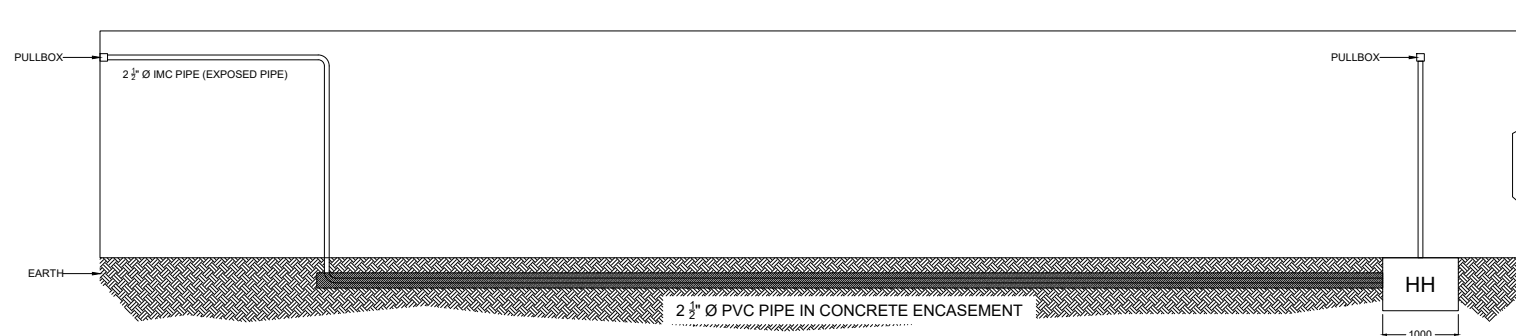

SECTION B-B DETAIL

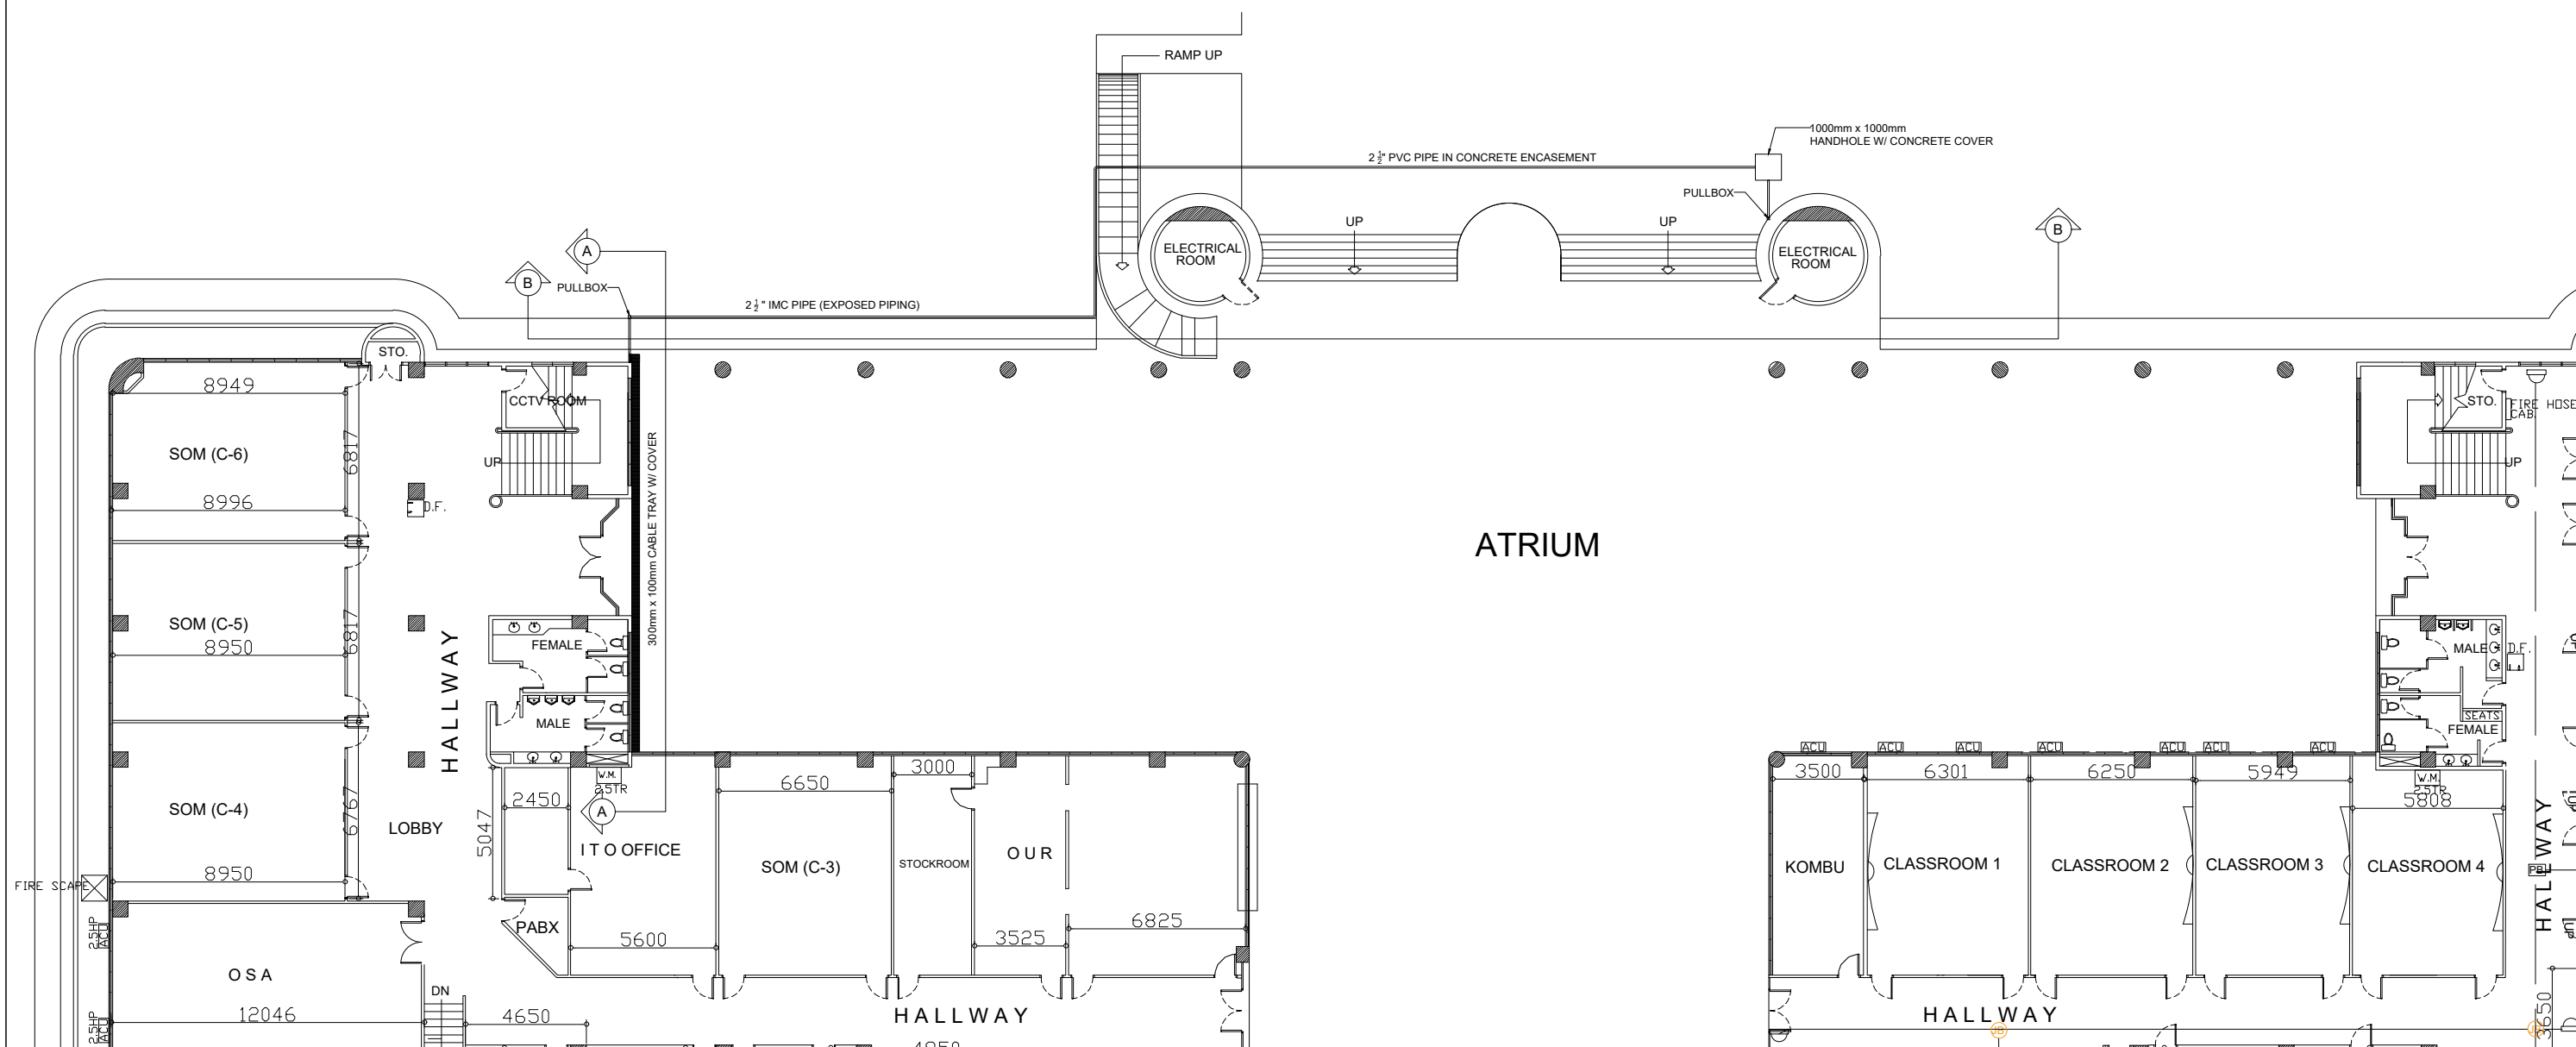

ATRIUM

E POWER LAYOUT
11 SCALE NTS

UNIVERSITY OF THE PHILIPPINES in MINDANAO	PROJECT	SHEET TITLE	REVISIONS/ADDITIONALS	SHEET NO.
	CENTRAL ADMINISTRATION BUILDING DATA CENTER	DATA CENTER SINGLE LINE DIAGRAM		
PREPARED BY:	OWNER			
CONTRACTOR	UNIVERSITY OF THE PHILIPPINES in MINDANAO			